


Legend  
 EEP - Existing Iron Pipe  
 EFM - Existing FM  
 ECM - Existing Concrete Alignment  
 SSM - SSI Marker

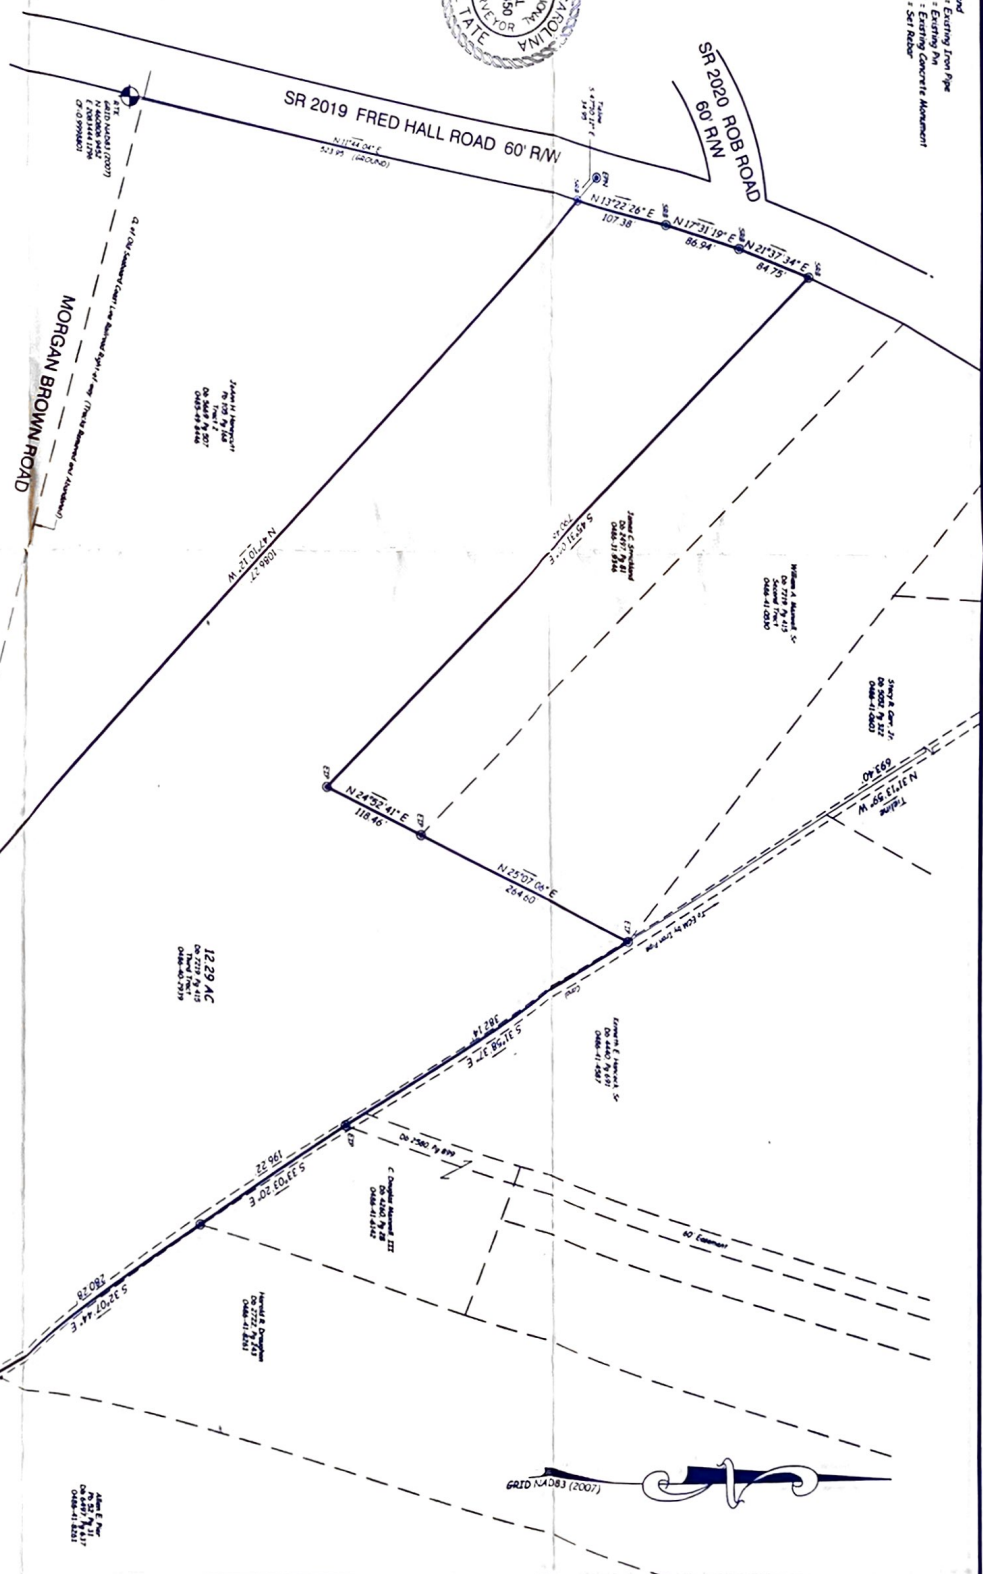

I, MICHAEL TATE, certify that this map and data were prepared from an on-site survey made under my supervision and that the accuracy of the data is guaranteed by the provisions of the laws of North Carolina. A true and correct copy of this map and data is attached to a deed as an exhibit to be recorded per 63-89C-76.

MICHAEL TATE, Professional Land Surveyor No. L-2450



GRAPHIC SCALE  
 ( IN FEET )  
 1 inch = 100 ft.

SURVEY FOR  
**DONALD K. COLEMAN and wife, MELINDA COLEMAN**  
 CEDAR CREEK TOWNSHIP ~ CUMBERLAND COUNTY  
 NORTH CAROLINA

MICHAEL TATE PROFESSIONAL LAND SURVEYOR 3521 CLINTON RD, FAYETTEVILLE, NC 28312 PHONE 910-483-7387	DRAWN BY: GES	CHECKED BY: MT
DATE: 08-11-08	SCALE: 1"=100'	
PARCEL NO. 0486-40-2939	JOB NO. 2906	DWG NO. 2906-1
		SHEET 1